


### Framing for Exterior Door "A"

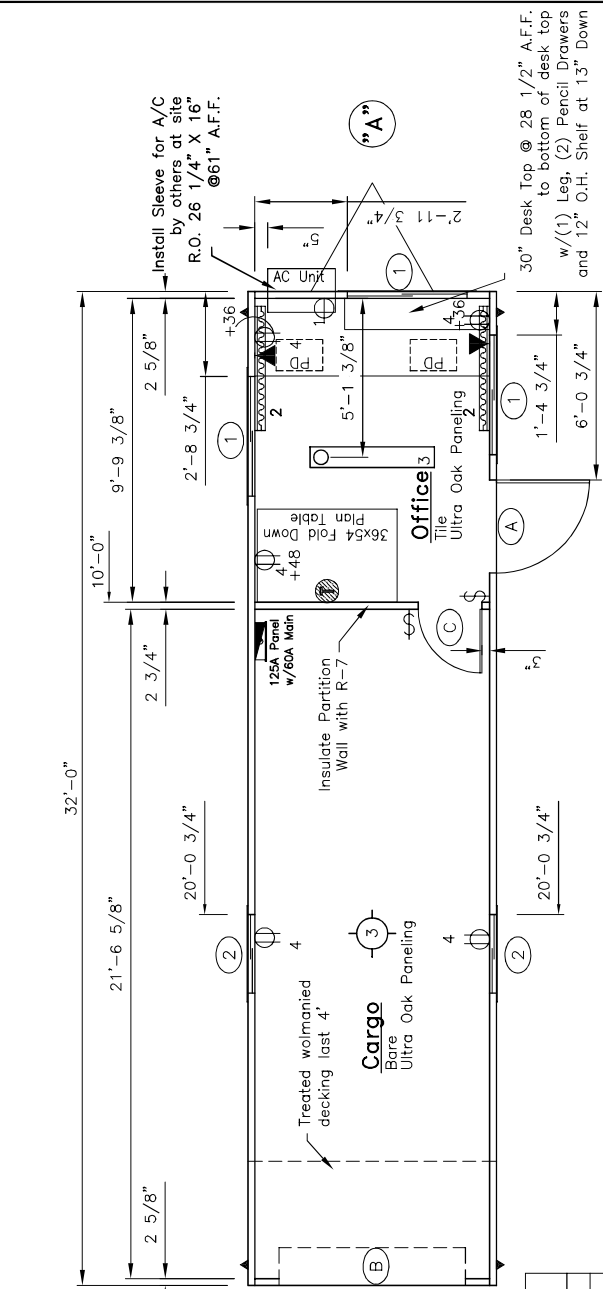

SYMBOL	QTY.	DESCRIPTION
▲	2	Over the Floor hurricane straps/Tie down locations
▬	1	120V/240 electric panel
▬	2	120V Electric 48" baseboard heater (+4" A.F.F.)
⊕	1	Thermostat (+54" A.F.F.)
⊕	5	120V ivory duplex grounding type (+18" AFF unless noted)
⊕	1	120V ivory single A/C Recept (+54" AFF)
◀	2	2x4-jbox w/3/4" conduit thru floor for phone/data (+36" AFF unless noted)
⊕	2	120V ivory toggle type (+48" AFF unless noted)
□	1	120V 4' (2) tube surface mount w/diffuser
⊕	1	120V Porcelain base incandescent light

**APPROVED FOR PRODUCTION**

Module:	A	B	C	Panel Voltage	Panel Phase	250 ft	240
Area served				60A			1
Main Breaker				60A			1
Qty				1.00			940
Description				1.00			940
Voltage				1.00			940
Wattage per item				1.00			940
Connected Load				1.00			940
Load Factor				1.00			940
Calculated Load				1.00			940
Total				1.00			940
Actual light load				1.00			940
TOL - A/C				1.00			940
NEC LT load factor				1.00			940
Total Load				1.00			940
Panel load amps				1.00			940

Module:	A	B	C	Panel Voltage	Panel Phase	250 ft	240
Area served				60A			1
Main Breaker				60A			1
Qty				1.00			940
Description				1.00			940
Voltage				1.00			940
Wattage per item				1.00			940
Connected Load				1.00			940
Load Factor				1.00			940
Calculated Load				1.00			940
Total				1.00			940
Actual light load				1.00			940
TOL - A/C				1.00			940
NEC LT load factor				1.00			940
Total Load				1.00			940
Panel load amps				1.00			940

**Electrical Riser Diagram**  
NTS

SYMBOL	QTY.	DESCRIPTION
⊕	2	36x80 standard vinyl clad door w/alum. frame and 10x10 safety glazed lite stay chain, knob lock set, weatherstripping, minigutter and threshold
□	1	72 X 68 Steel roll-up overhead w/minigutter
⊕	1	24x80 hollow core door w/factory frame and passage knob set
⊕	3	46x27 horizontal slider w/aluminum mill frame single glass, blinds and bug screen
⊕	2	30x14 horizontal slider w/aluminum mill frame single obscure glass and bug screen

SYMBOL	QTY.	DESCRIPTION
⊕	2	36x80 standard vinyl clad door w/alum. frame and 10x10 safety glazed lite stay chain, knob lock set, weatherstripping, minigutter and threshold
□	1	72 X 68 Steel roll-up overhead w/minigutter
⊕	1	24x80 hollow core door w/factory frame and passage knob set
⊕	3	46x27 horizontal slider w/aluminum mill frame single glass, blinds and bug screen
⊕	2	30x14 horizontal slider w/aluminum mill frame single obscure glass and bug screen

SYMBOL	QTY.	DESCRIPTION
⊕	2	36x80 standard vinyl clad door w/alum. frame and 10x10 safety glazed lite stay chain, knob lock set, weatherstripping, minigutter and threshold
□	1	72 X 68 Steel roll-up overhead w/minigutter
⊕	1	24x80 hollow core door w/factory frame and passage knob set
⊕	3	46x27 horizontal slider w/aluminum mill frame single glass, blinds and bug screen
⊕	2	30x14 horizontal slider w/aluminum mill frame single obscure glass and bug screen

**Dear John Inc.**  
2224 Bloomingdale Drive  
Bristol, Indiana 46507  
PH: (574) 848-7300  
FX: (574) 848-1950  
C & B  
MODULAR, INC.

**DOOR & WINDOW SCHEDULE**

**Production Floor / Electrical Plan**

**WIRE SIZE CHART**

Breaker Size	Wire Size	Breaker Size	Wire Size
15A	#14	80A	#4
20A	#12	90A	#3
30A	#10	100A	#3
40A	#8	115A	#2
50A	#8	130A	#1
60A	#6	150A	#1

**Revision**

ID	Revision	Date

**Scale:** 1/4" = 1'-0"

**Drawn:** BB

**Date:** 2/21/08

**Plot Date:** Feb 28, 2008

**Serial Numbers:** 828

**Drawing Number:** 828

**DWG File Name:** DJ1835C.dwg

**Approval Numbers:** MT 252784

**Title:** Dear John Trailers  
8 x 36 Combo (8'-0" x 32'-0")

**Sheet Description:** Production Floor / Electrical Plan

**Page #:** A2